


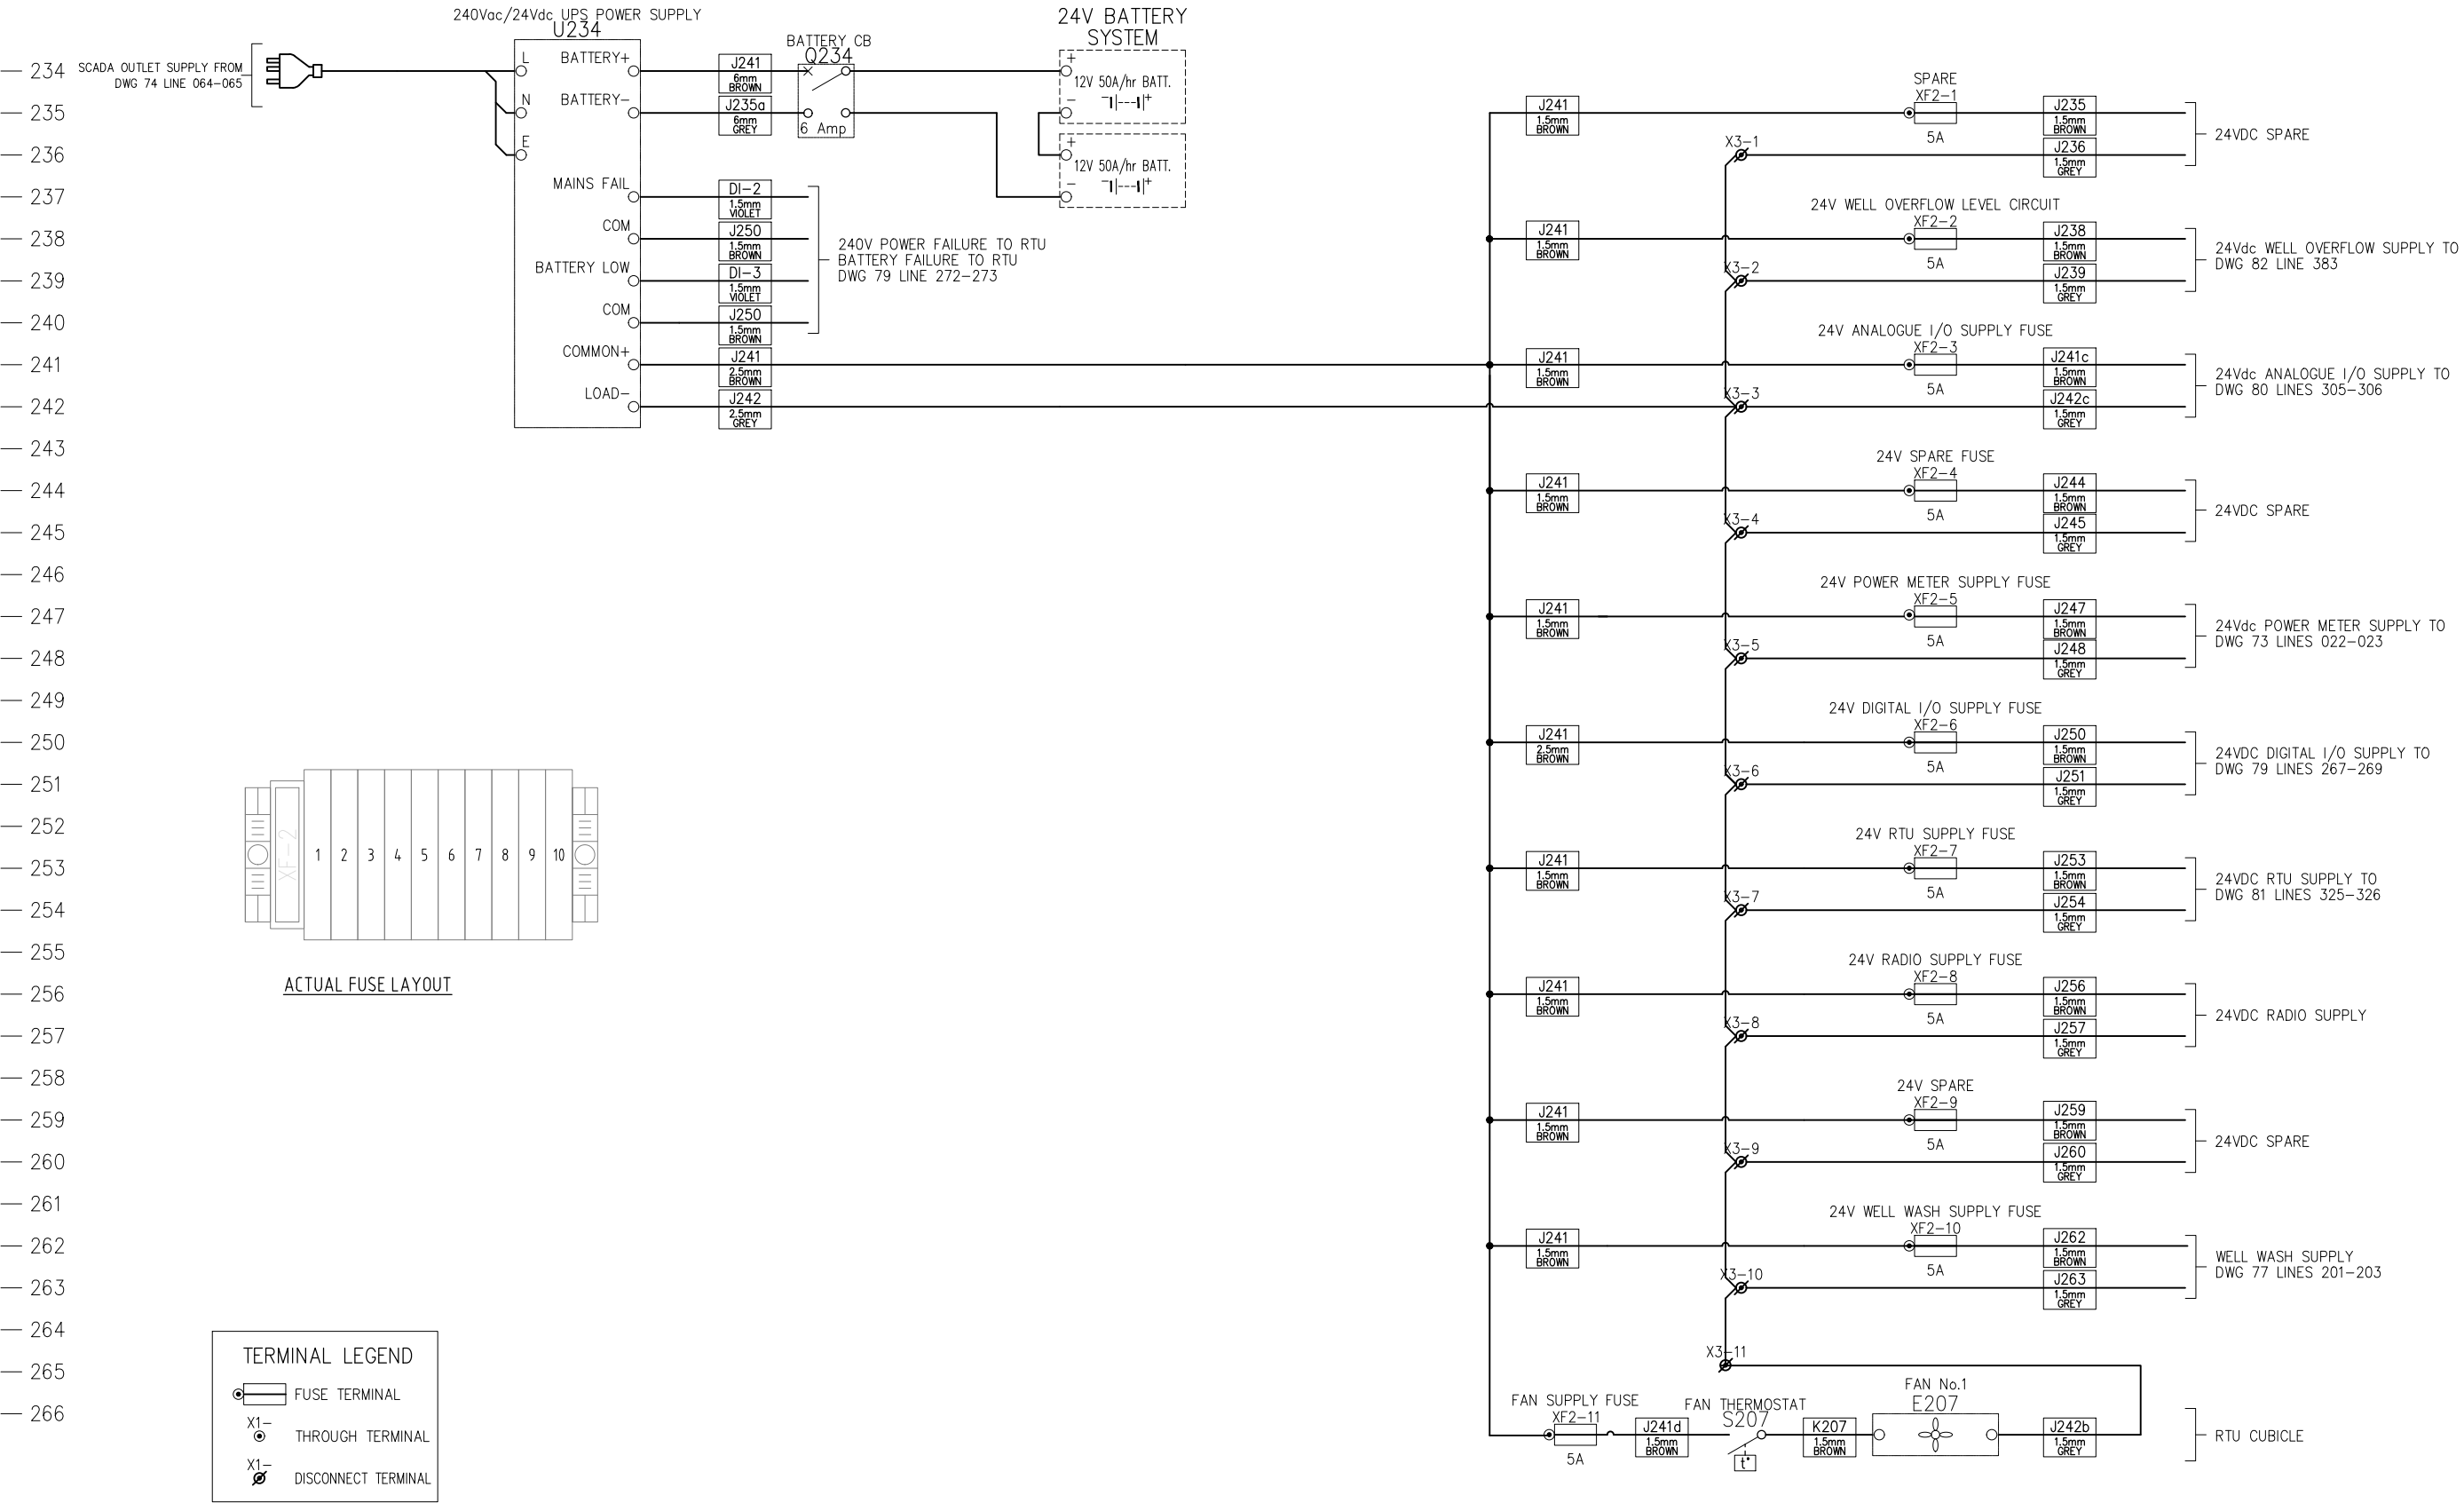

AMENDMENTS			
REV	DESCRIPTION	CHECKED	DATE
0	ISSUED FOR REFERENCE		

PRINTED ON Friday, 8 August 2025 3:25:41 PM BY Roseben Enriquez



GLADSTONE REGIONAL COUNCIL

P.O. Box 29, Gladstone Qld. 4680

STANDARD DRAWING
DUAL SEWERAGE PUMP STATION
SWITCHBOARD <4KW VSD
CONTROL SCHEMATIC 2 - 12V & 24V DC CONTROL

DRAWING NO.
GRC-ED-078

A1 SHEET REVISION 0