


AMENDMENTS			
REV	DESCRIPTION	CHECKED	DATE
0	ISSUED FOR REFERENCE		

PRINTED ON Friday, 8 August 2025 3:25:42 PM BY Roseben Enriquez

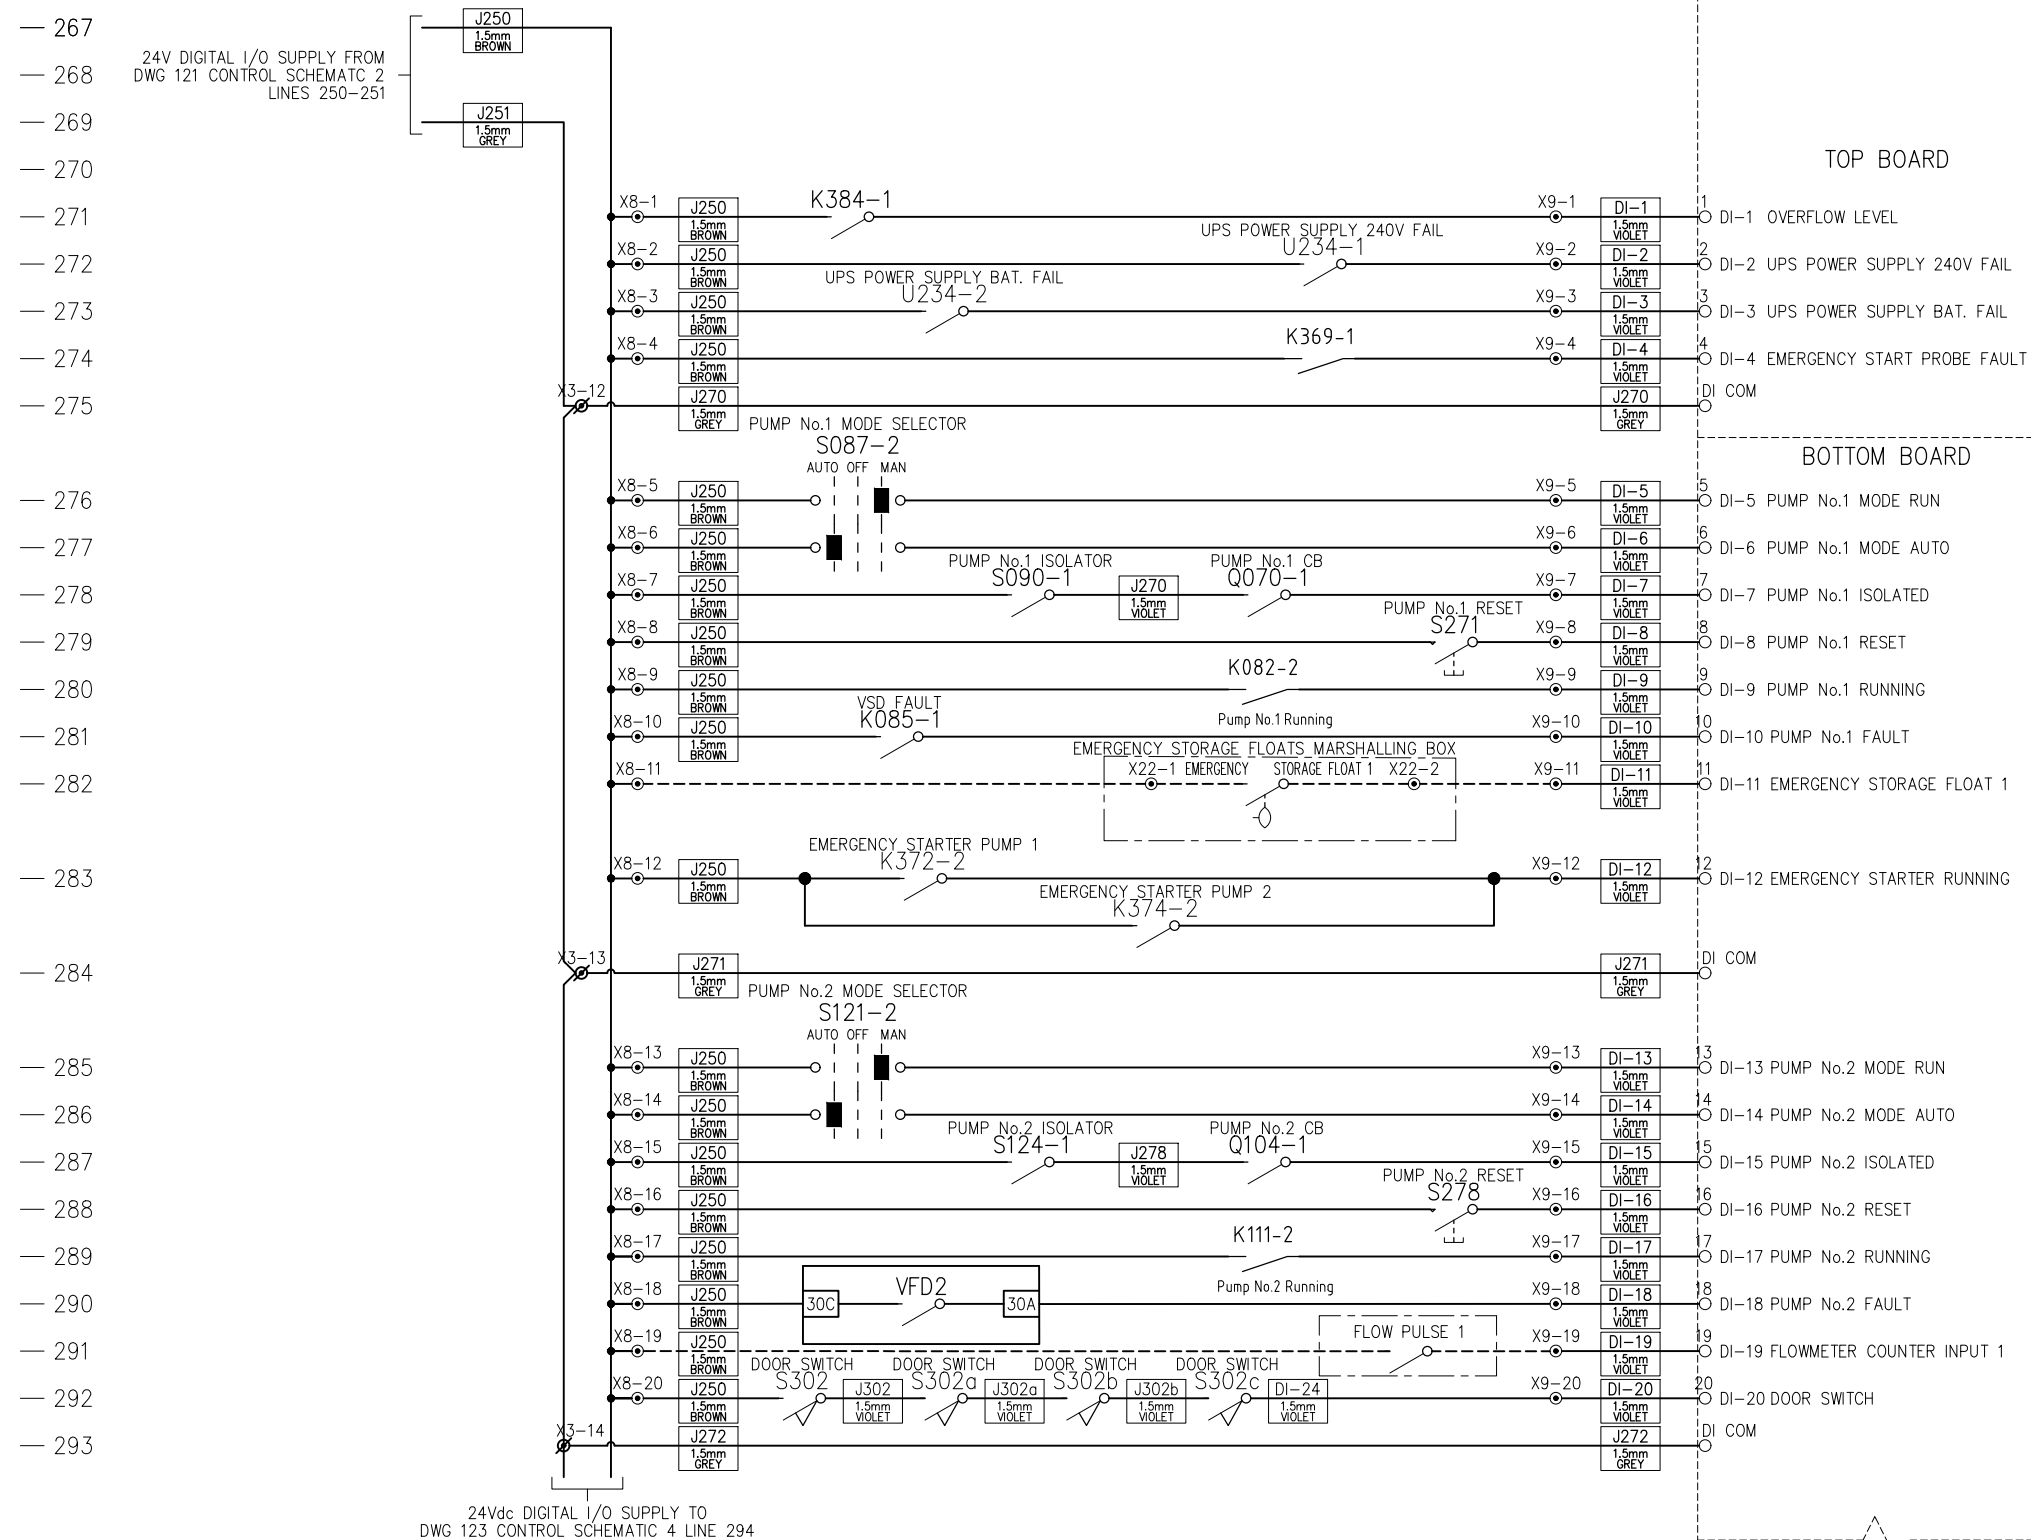

**GLADSTONE REGIONAL
COUNCIL**

P.O. Box 29, Gladstone Qld. 4680

STANDARD DRAWING
DUAL SEWERAGE PUMP STATION
SWITCHBOARD <4KW VSD
CONTROL SCHEMATIC 3 - DIGITAL INPUT ARRANGEMENT

DRAWING NO.

GRC-ED-079

A1 SHEET

REVISION

0