


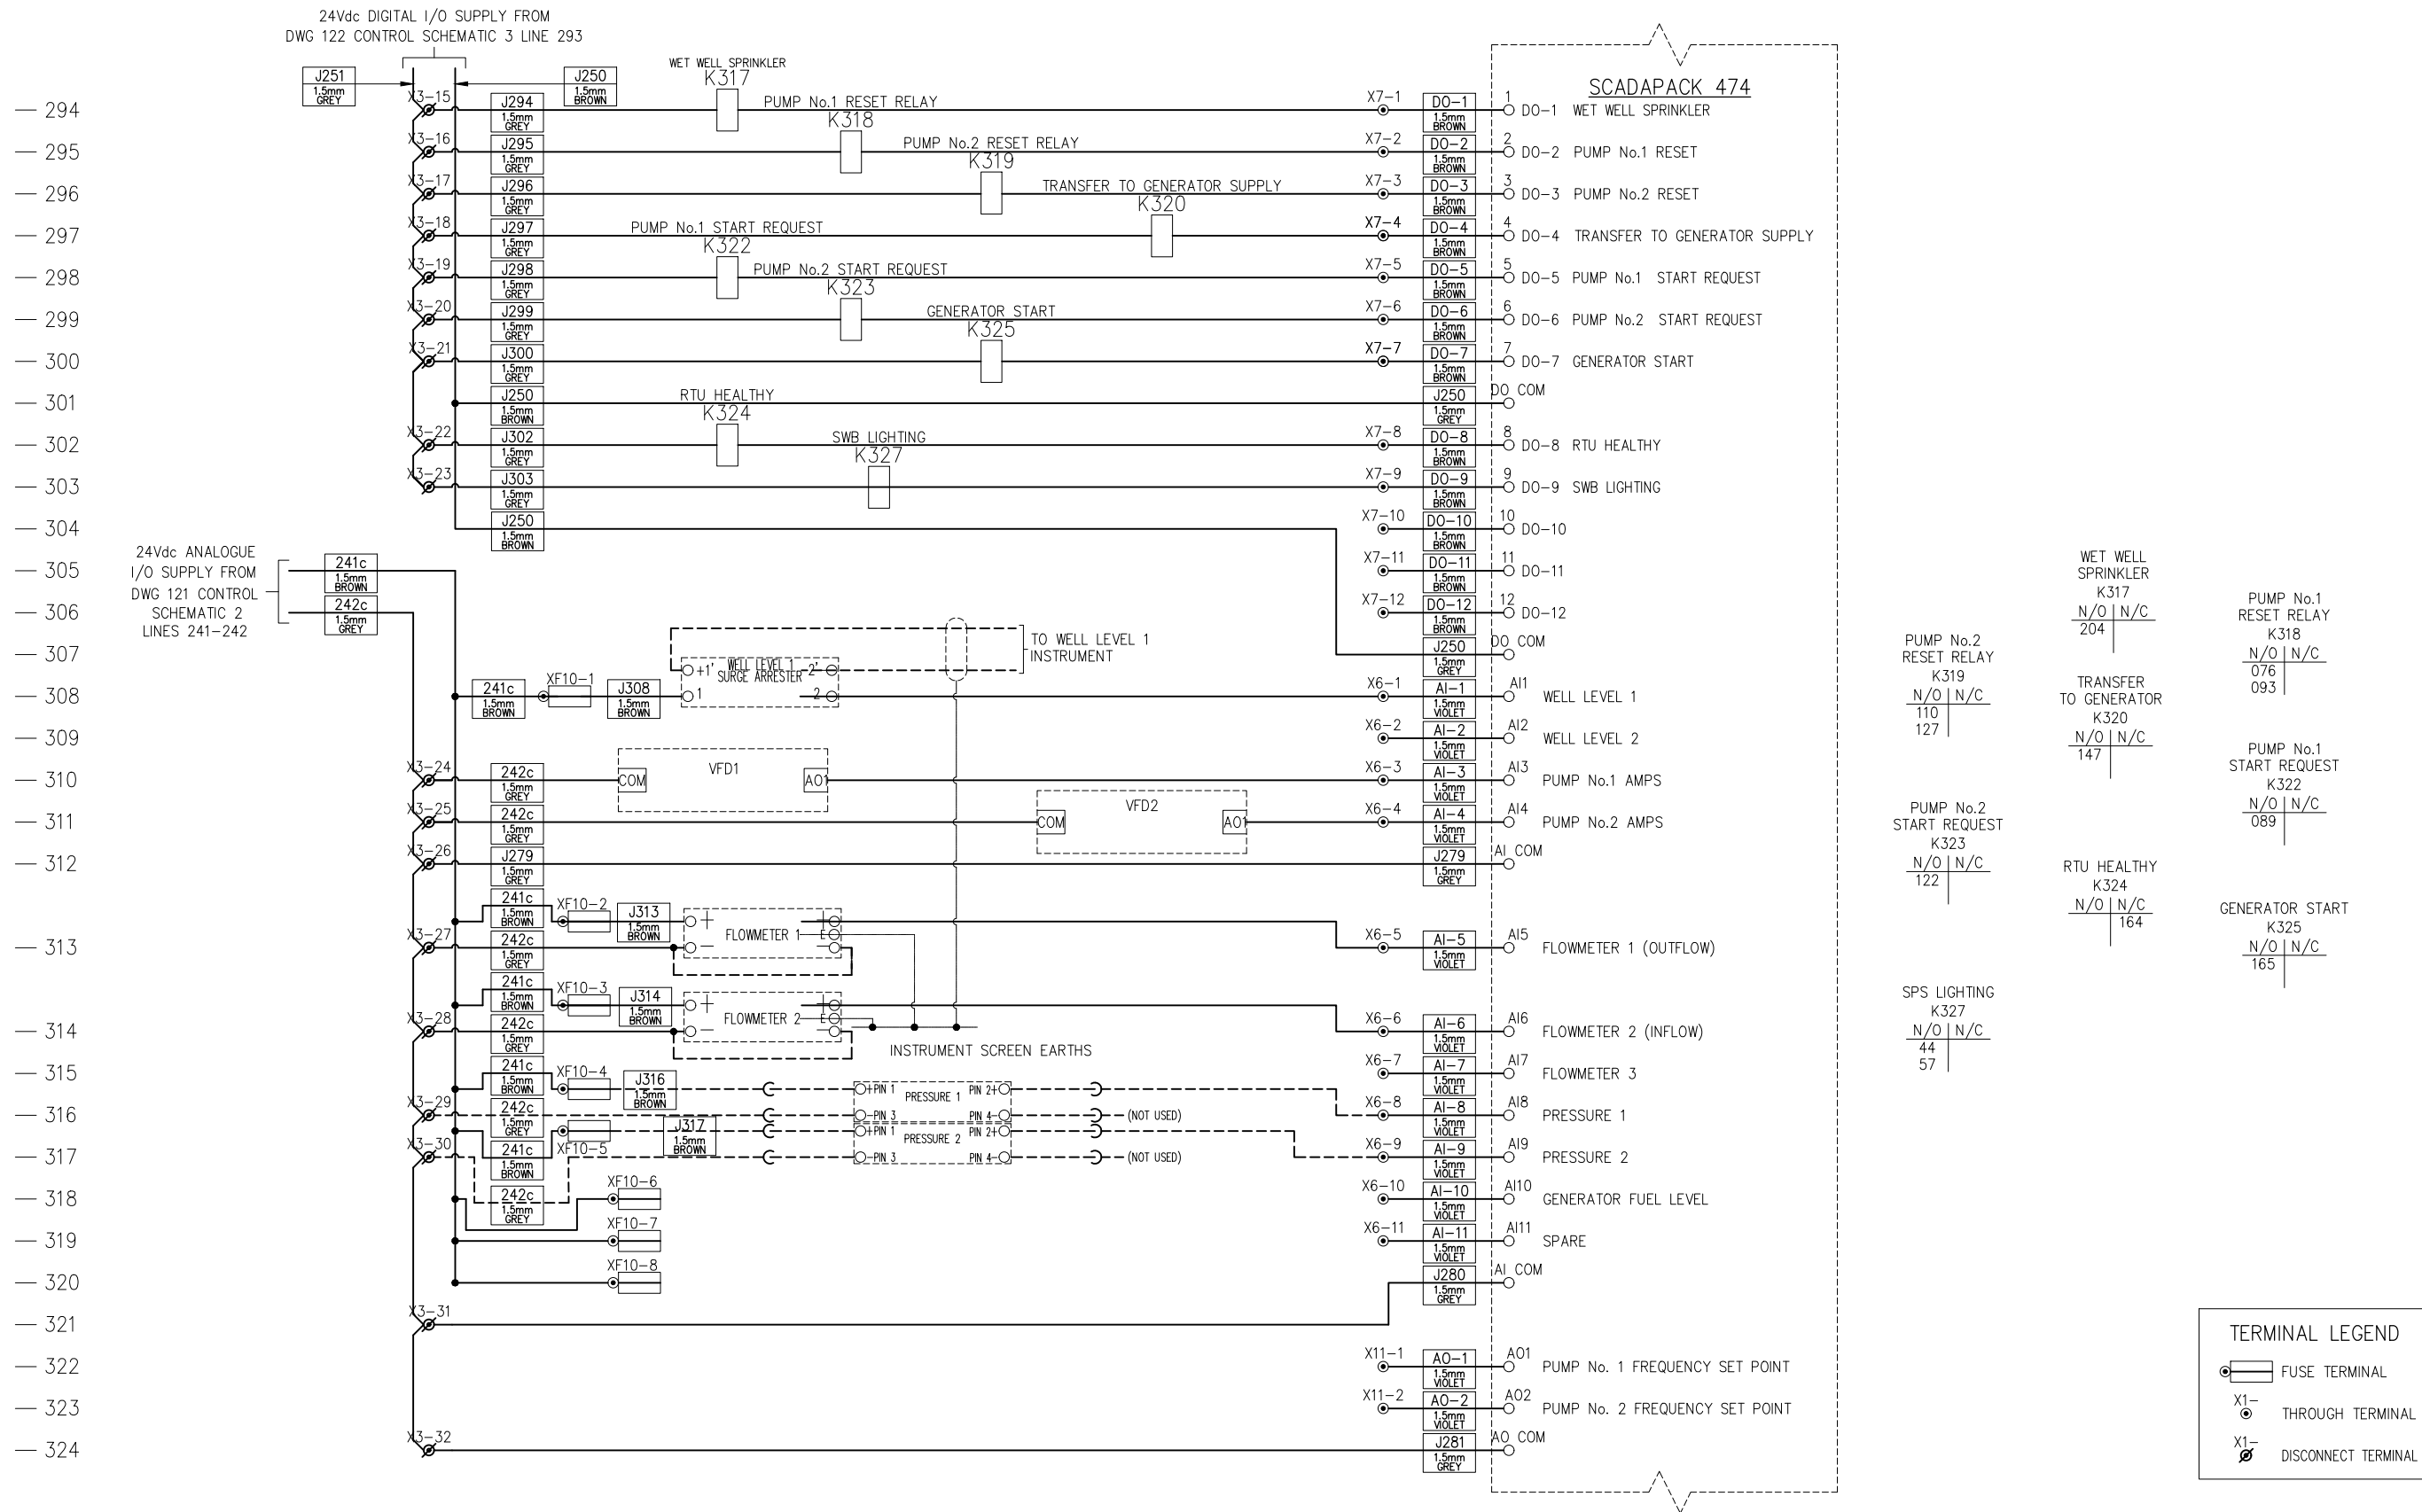

AMENDMENTS			
REV	DESCRIPTION	CHECKED	DATE
0	ISSUED FOR REFERENCE		

GLADSTONE REGIONAL COUNCIL

P.O. Box 29, Gladstone Qld. 4680

STANDARD DRAWING
DUAL SEWERAGE PUMP STATION
SWITCHBOARD <4KW VSD
CONTROL SCHEMATIC 4 - DIGITAL INPUT & OUTPUT ARRGT'

DRAWING NO.
GRC-ED-080

A1 SHEET REVISION 0