


— 201
— 202
— 203
— 204
— 205
— 206
— 207
— 208
— 209
— 210
— 211
— 212
— 213
— 214
— 215
— 216
— 217
— 218
— 219
— 220
— 221
— 222
— 223
— 224
— 225
— 226
— 227
— 228
— 229
— 230
— 231
— 232
— 233

WELL WASHER SUPPLY
(DWG 98 CONTROL SCHEMATIC 2 LINE 262)

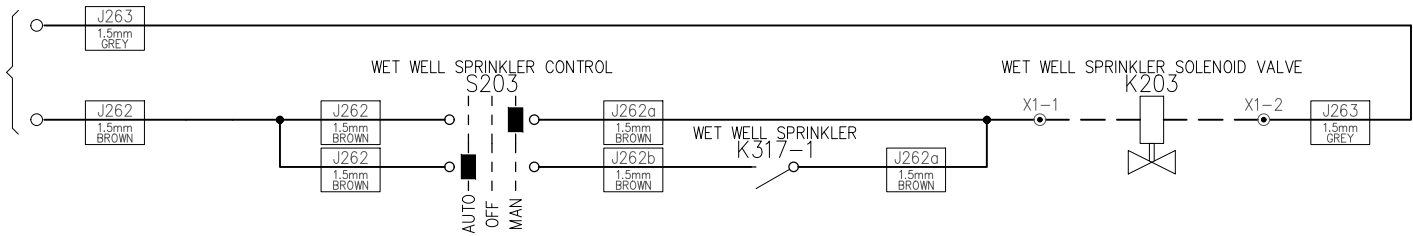

TERMINAL LEGEND	
	FUSE TERMINAL
	THROUGH TERMINAL
	DISCONNECT TERMINAL

AMENDMENTS			
REV	DESCRIPTION	CHECKED	DATE
0	ISSUED FOR REFERENCE		



GLADSTONE REGIONAL COUNCIL

P.O. Box 29, Gladstone Qld. 4680

STANDARD DRAWING
DUAL SEWERAGE PUMP STATION
SWITCHBOARD 4-22KW VSD
CONTROL SCHEMATIC 1

DRAWING NO.
GRC-ED-097

A1 SHEET	REVISION	0
----------	----------	---