


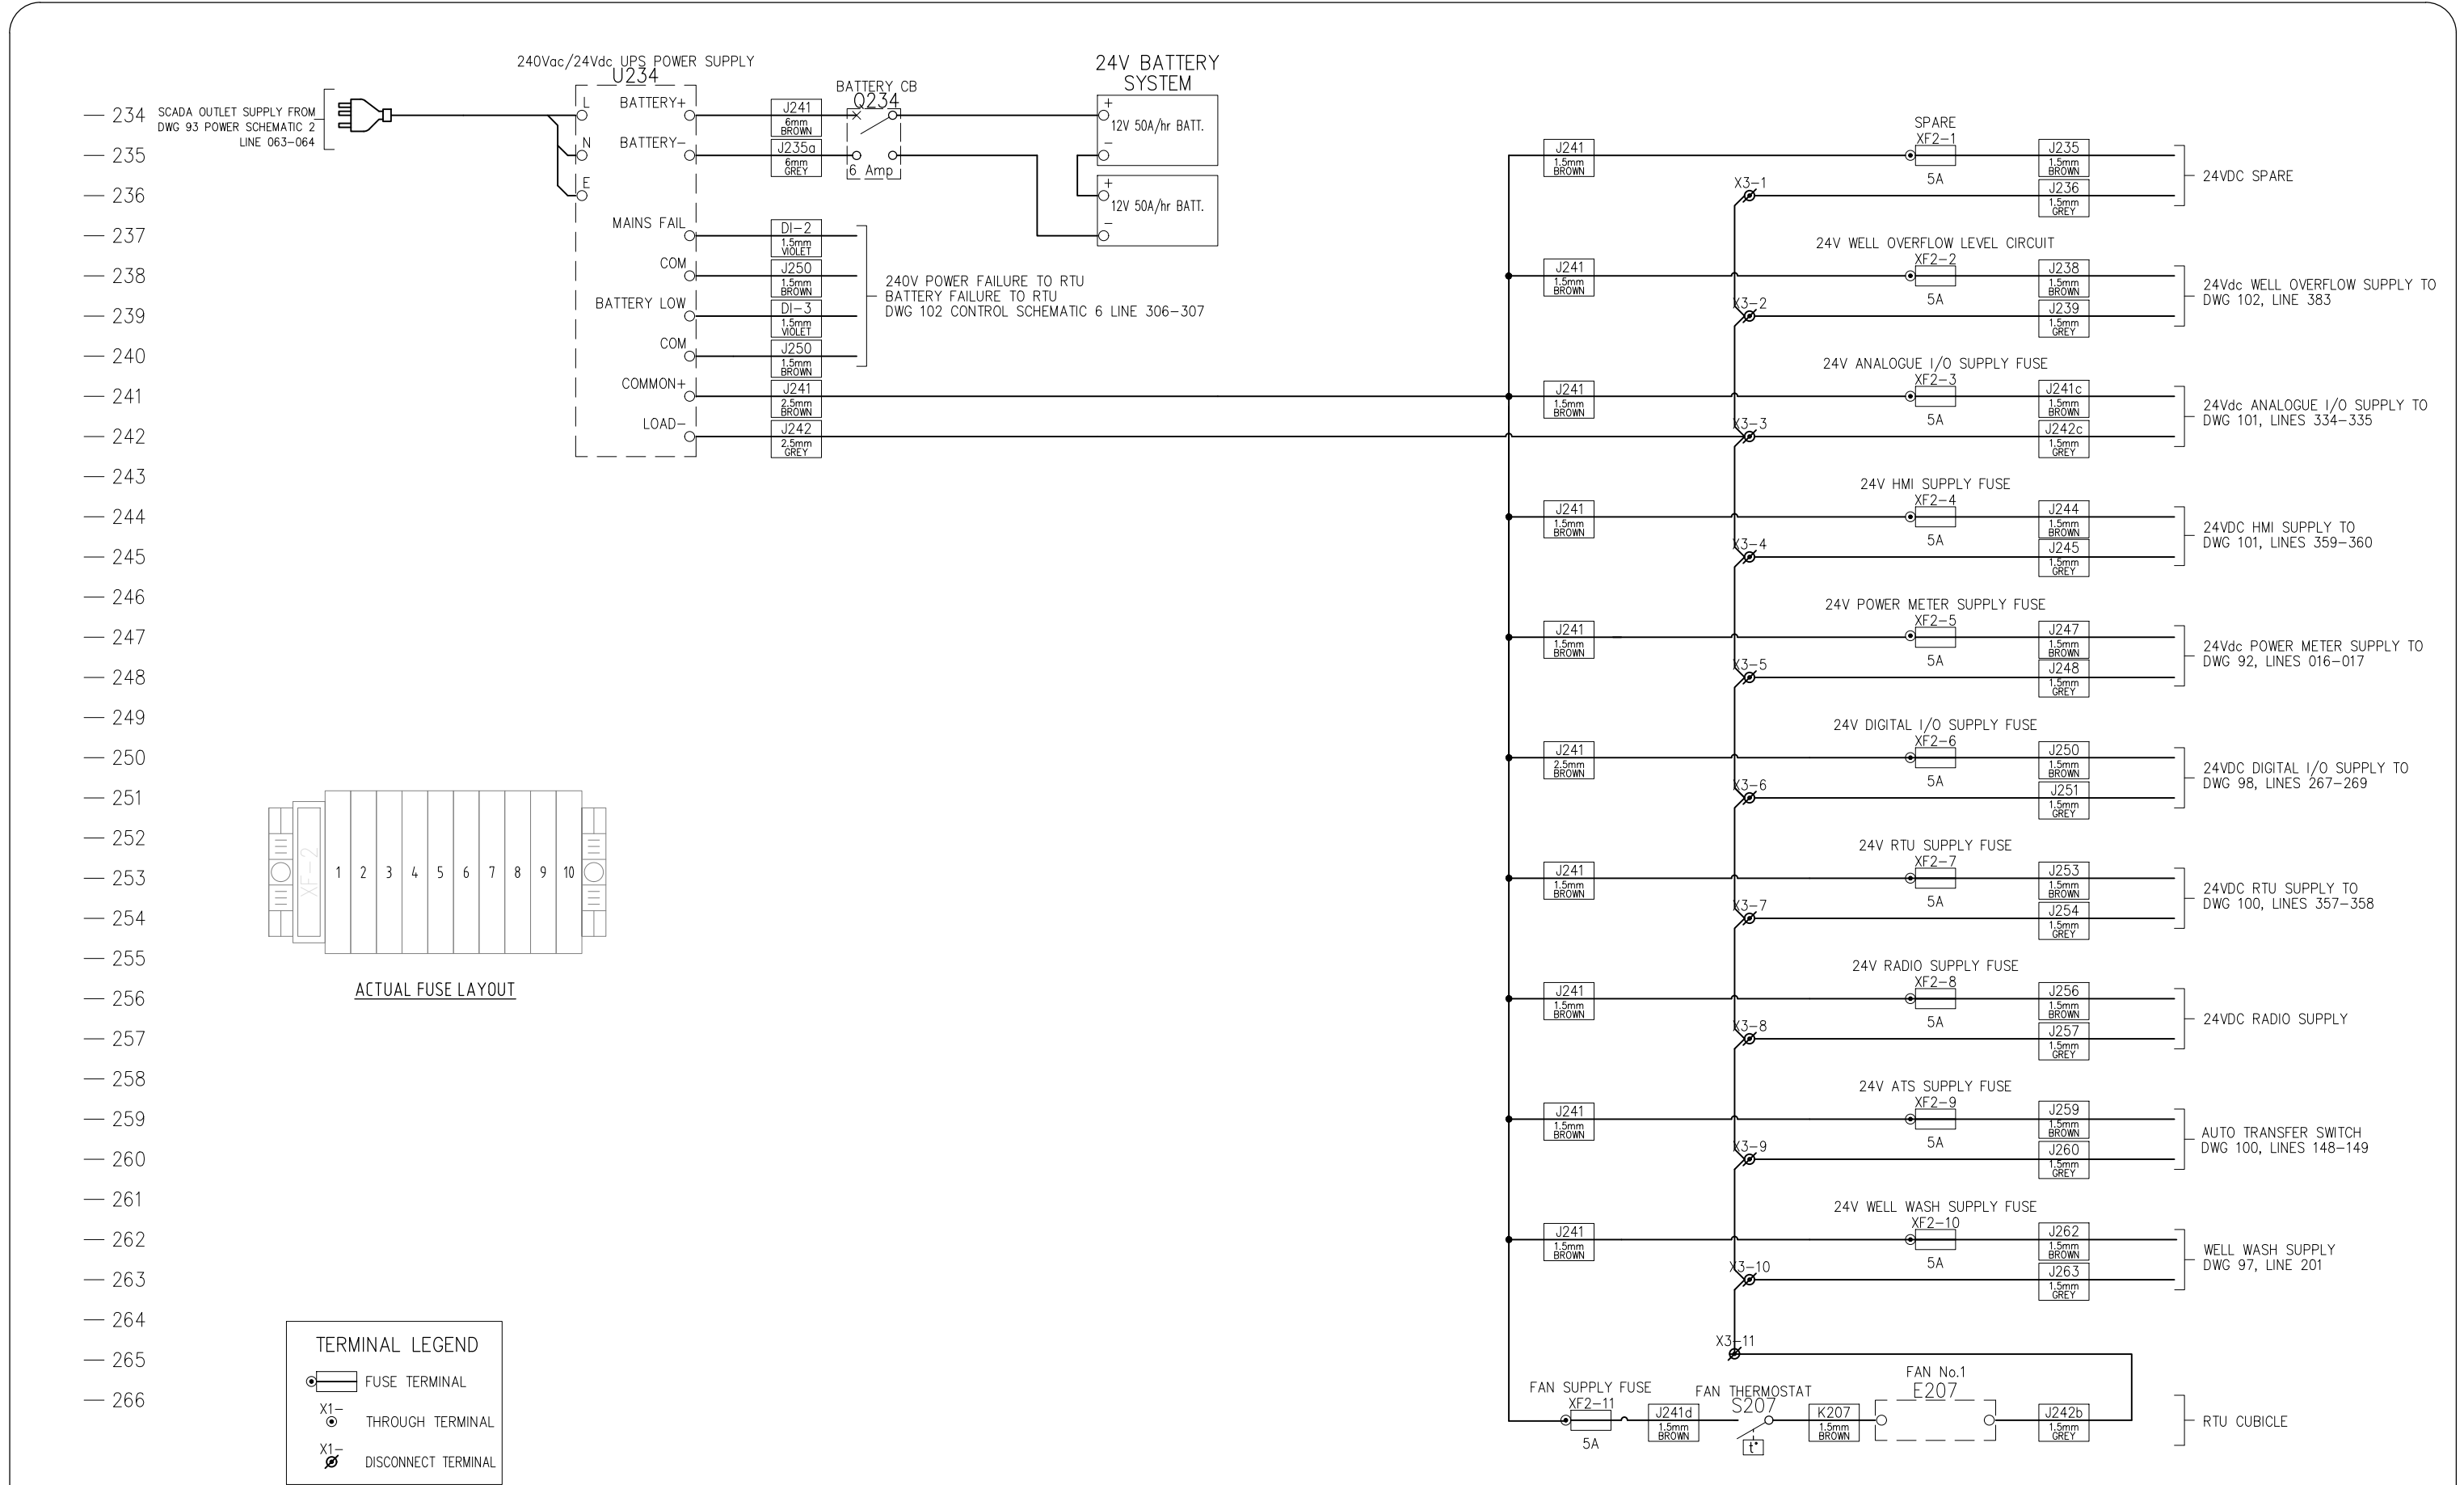

AMENDMENTS			
REV	DESCRIPTION	CHECKED	DATE
0	ISSUED FOR REFERENCE		

PRINTED ON Friday, 8 August 2025 3:22:09 PM BY Roseben Enriquez



GLADSTONE REGIONAL
COUNCIL

P.O. Box 29, Gladstone Qld. 4680

STANDARD DRAWING
DUAL SEWERAGE PUMP STATION
SWITCHBOARD 4-22KW VSD
CONTROL SCHEMATIC 2 - 12V & 24V DC CONTROL

DRAWING NO.
GRC-ED-098

A1 SHEET	REVISION	0
----------	----------	---