


— 294
— 295
— 296
— 297
— 298
— 299
— 300
— 301
— 302
— 303
— 304
— 305
— 306
— 307
— 308
— 309
— 310
— 311
— 312
— 313
— 314
— 315
— 316
— 317
— 318
— 319
— 320
— 321
— 322
— 323
— 324

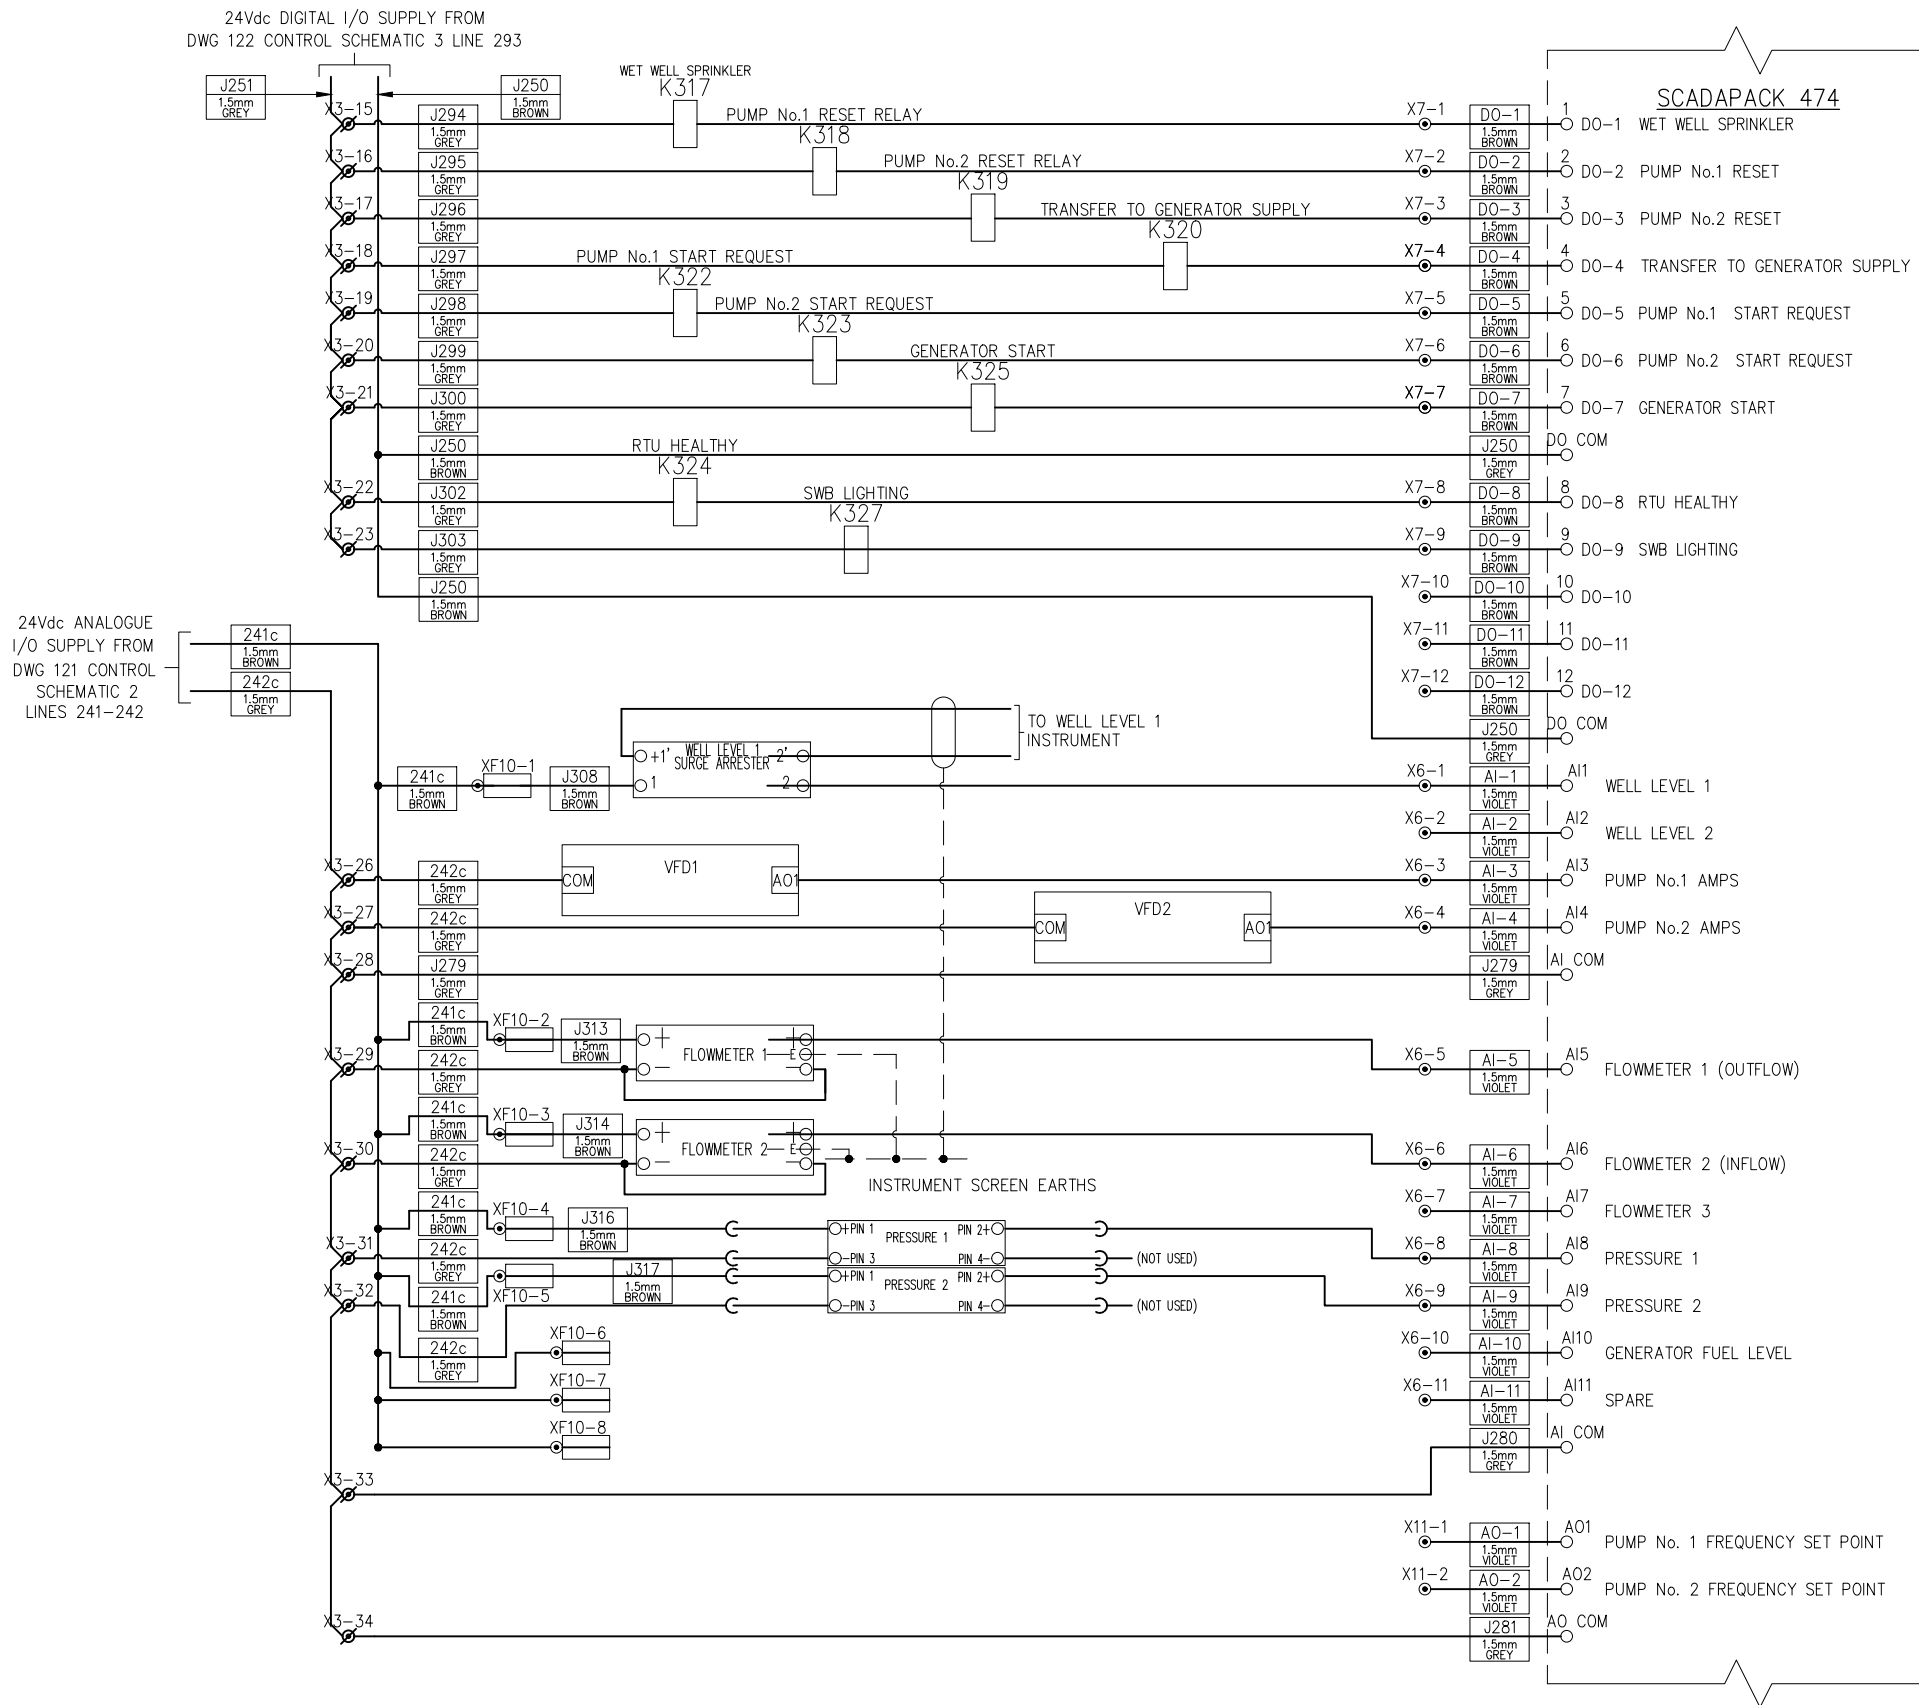

TERMINAL LEGEND	
	FUSE TERMINAL
	THROUGH TERMINAL
	DISCONNECT TERMINAL

AMENDMENTS			
REV	DESCRIPTION	CHECKED	DATE
0	ISSUED FOR REFERENCE		



GLADSTONE REGIONAL
COUNCIL

P.O. Box 29, Gladstone Qld. 4680

STANDARD DRAWING
DUAL SEWERAGE PUMP STATION
SWITCHBOARD 4-22KW VSD
CONTROL SCHEMATIC 4 - DIGITAL INPUT & OUTPUT ARRGT

DRAWING NO.
GRC-ED-100

A1 SHEET	REVISION	0
----------	----------	---