


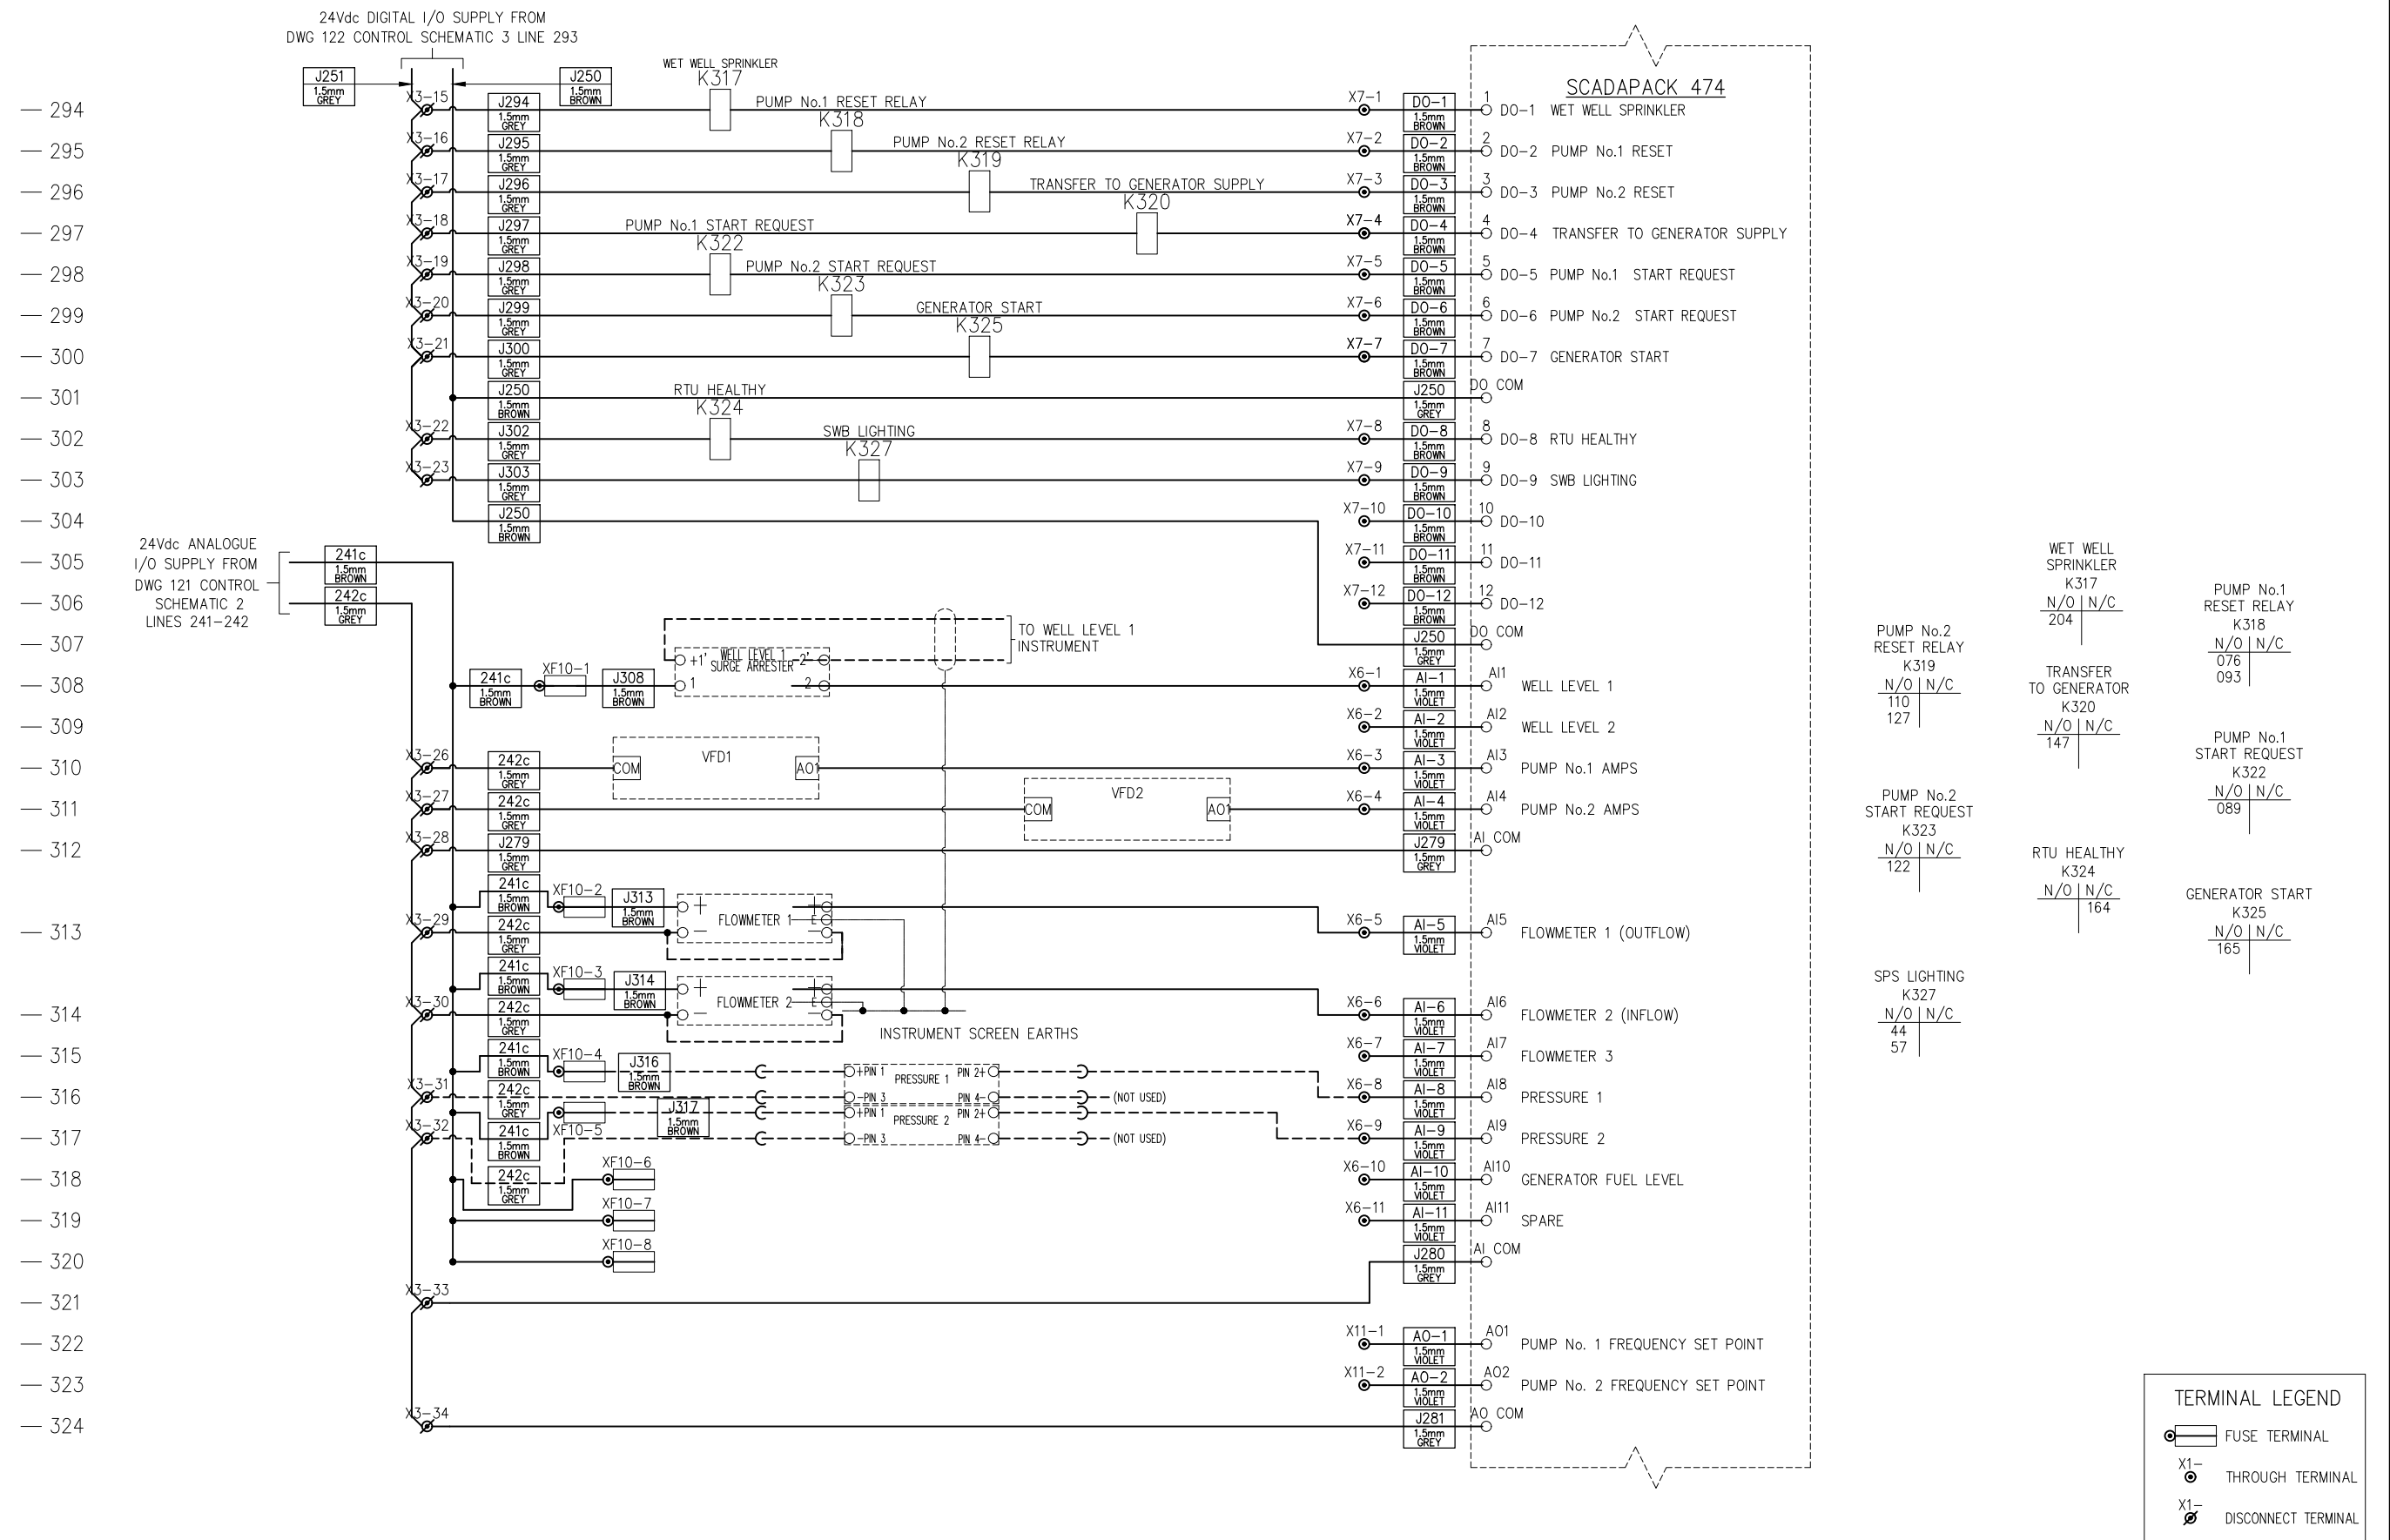

AMENDMENTS			
REV	DESCRIPTION	CHECKED	DATE
0	ISSUED FOR REFERENCE		



GLADSTONE REGIONAL
COUNCIL

P.O. Box 29, Gladstone Qld. 4680

STANDARD DRAWING
DUAL SEWERAGE PUMP STATION
SWITCHBOARD 22-160KW VSD
CONTROL SCHEMATIC 4 - ANALOGUE INPUT & OUTPUT ARRGT'

DRAWING NO.
GRC-ED-123

A1 SHEET

REVISION

0