


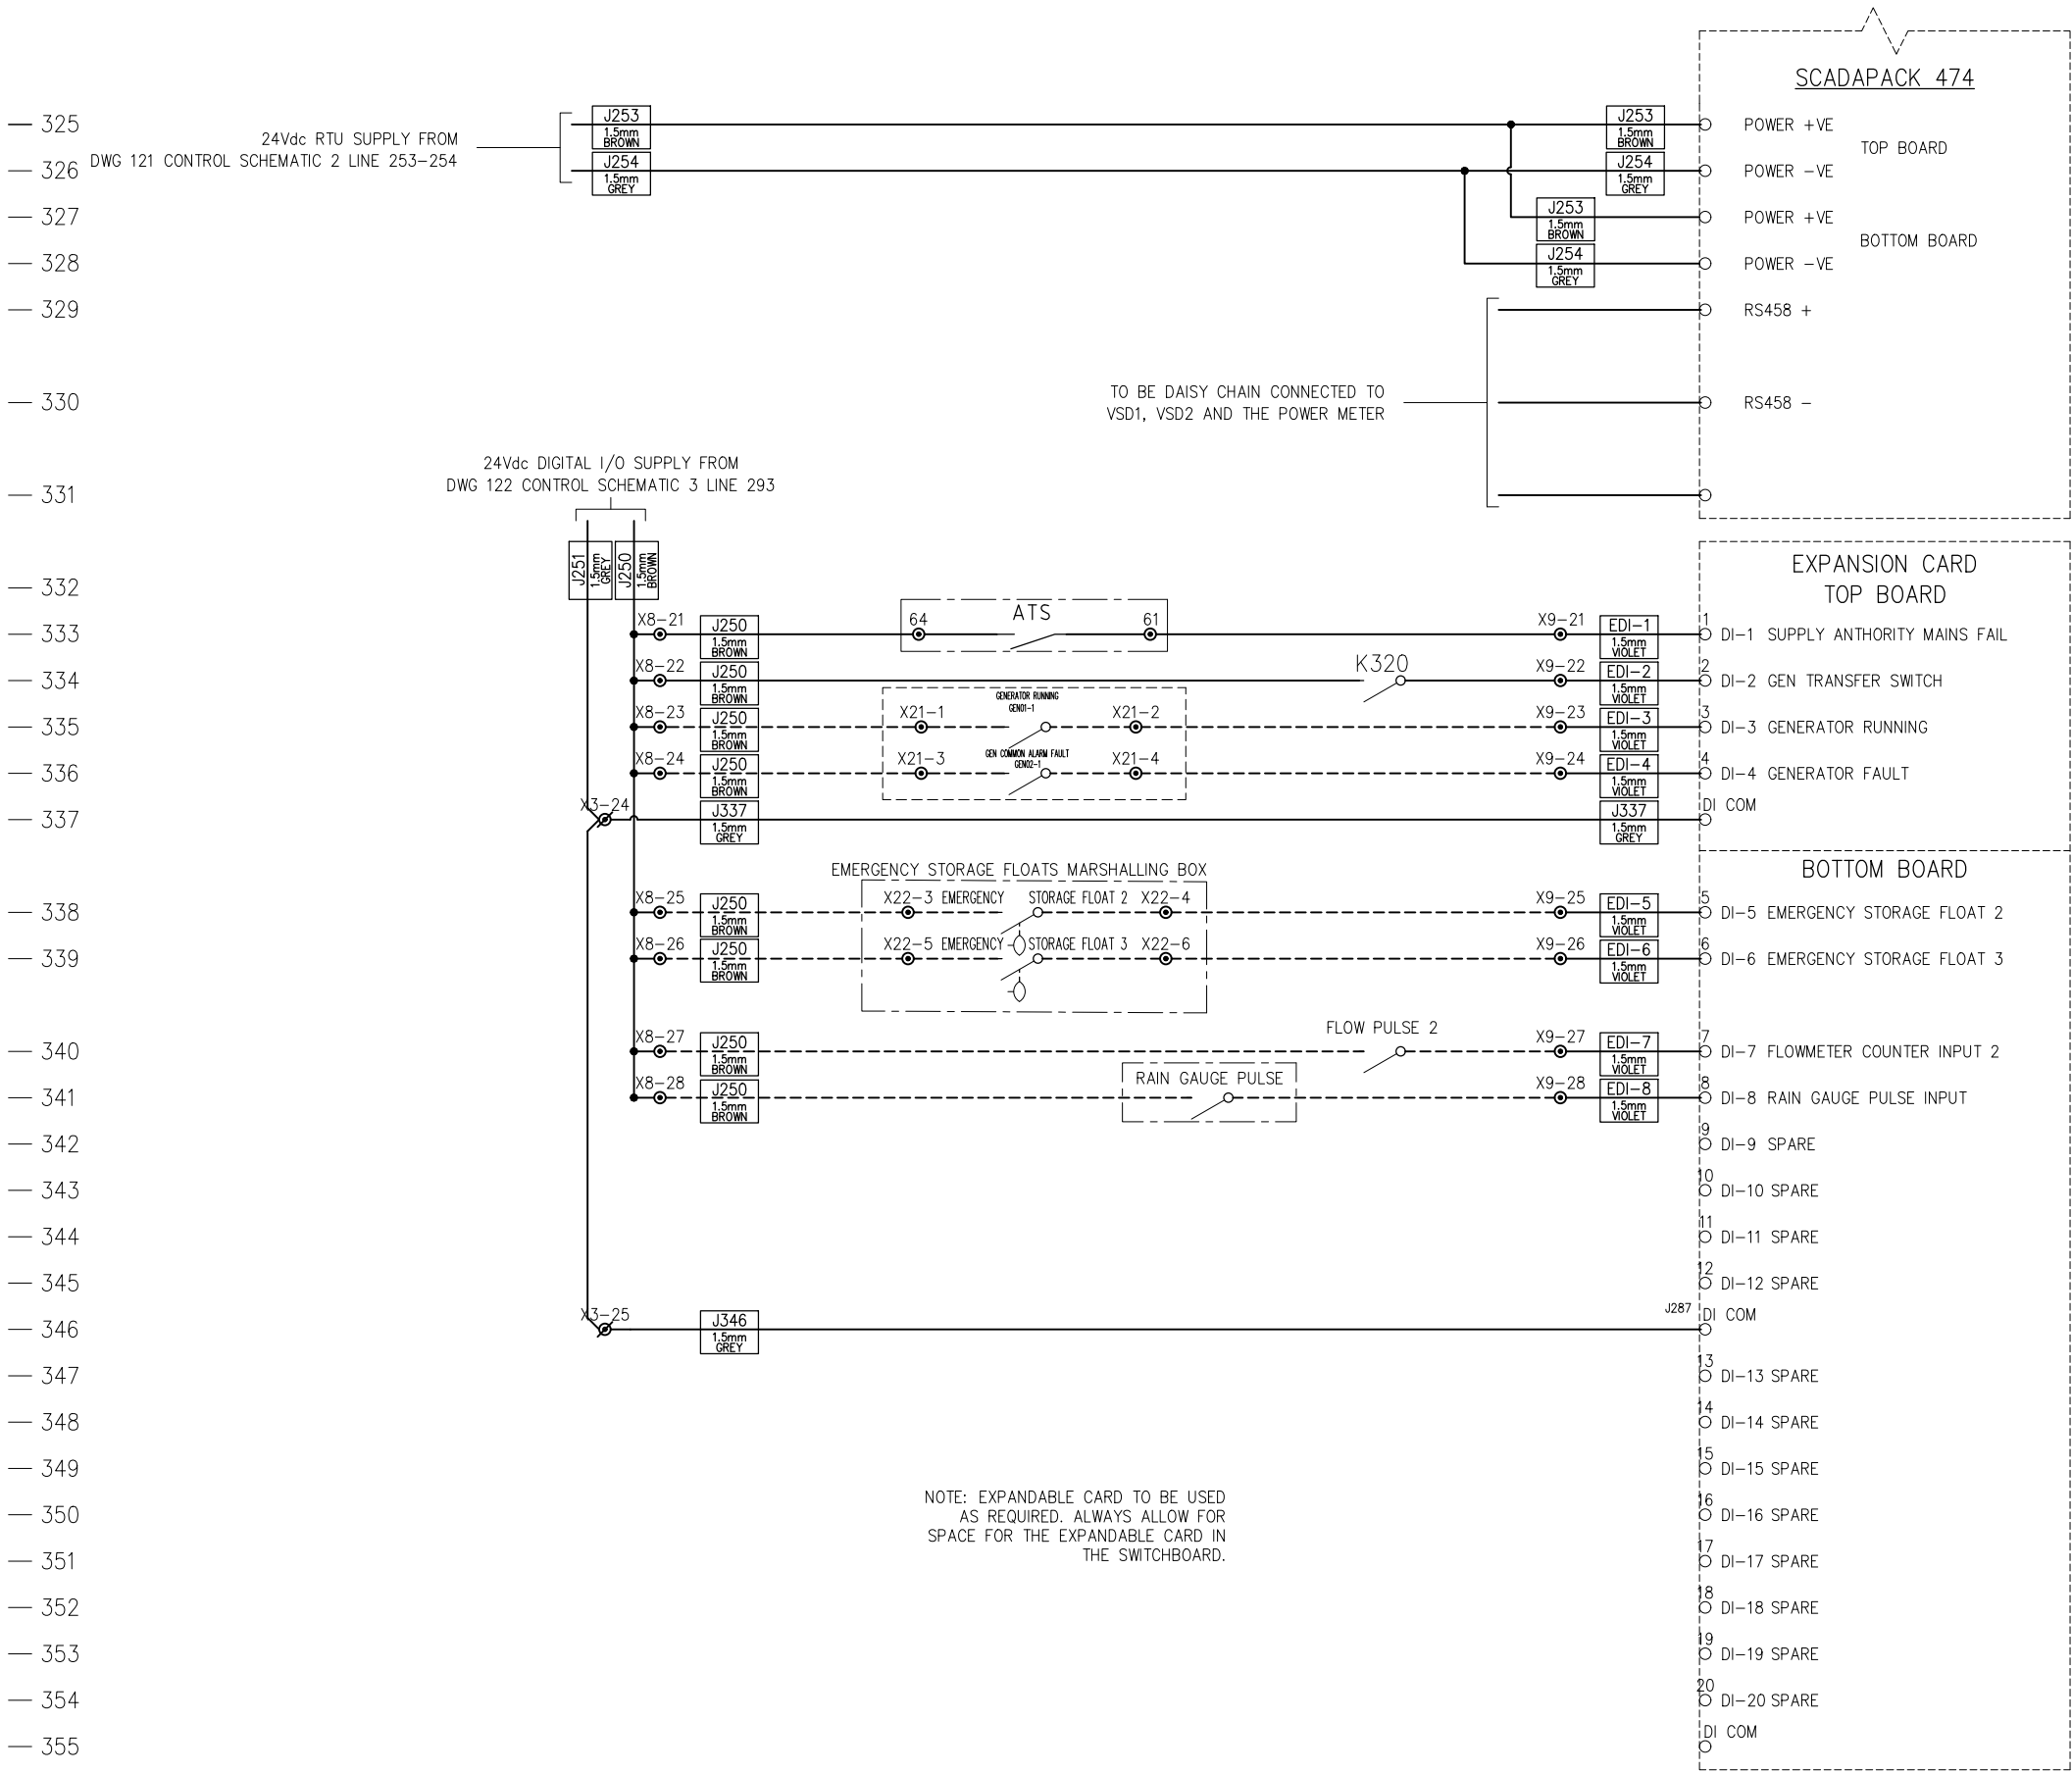

TERMINAL LEGEND

- FUSE TERMINAL
X1- THROUGH TERMINAL
X1- DISCONNECT TERMINAL

AMENDMENTS			
REV	DESCRIPTION	CHECKED	DATE
0	ISSUED FOR REFERENCE		



**GLADSTONE REGIONAL
COUNCIL**

P.O. Box 29, Gladstone Qld. 4680

STANDARD DRAWING
DUAL SEWERAGE PUMP STATION
SWITCHBOARD 22-160KW VSD
CONTROL SCHEMATIC 5 - ANALOGUE INPUTS & ACCESSORIES

DRAWING NO.

GRC-ED-124

A1 SHEET REVISION 0